


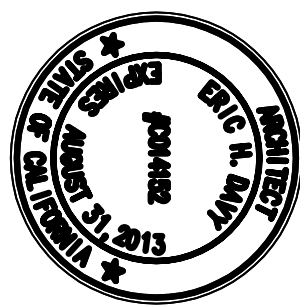

ALL FIELD MEASUREMENTS AND DIMENSIONS SHOWN ON THIS DRAWING ARE THE PROPERTY OF DAVY ARCHITECTS, INC. AND SHALL BE USED BY THE CLIENT FOR THE PROJECT ONLY. NO PART OF THIS DRAWING SHALL BE REPRODUCED OR TRANSMITTED IN ANY FORM OR BY ANY MEANS, ELECTRONIC OR MECHANICAL, INCLUDING PHOTOCOPYING, RECORDING, OR BY ANY INFORMATION STORAGE AND RETRIEVAL SYSTEM, WITHOUT THE WRITTEN PERMISSION OF DAVY ARCHITECTS, INC. THE CLIENT AGREES TO HOLD DAVY ARCHITECTS, INC. HARMLESS FROM AND AGAINST ALL CLAIMS, DAMAGES, LOSSES AND EXPENSES, INCLUDING REASONABLE ATTORNEY'S FEES, ARISING OUT OF OR RESULTING FROM THE USE OF THIS DRAWING BY THE CLIENT FOR ANY PURPOSE OTHER THAN THAT AUTHORIZED BY THE CLIENT'S AGREEMENT WITH DAVY ARCHITECTS, INC.

IDENTIFICATION STAMP
DIV. OF THE STATE ARCHITECT
OFFICE OF REGULATION SERVICES
APPL. 04-111851
AC: _____
DATE: _____

FS: _____
ACS: _____
SSS: _____


MONARCH SCHOOL

1625 NEWTON AVENUE, SAN DIEGO, CA

ISSUE	DATE
☐ CONCEPT DESIGN PLAN 09 JUNE '10	
☐ 100% SCHEMATIC DESIGN 06 JULY '10	
☐ 100% DESIGN DEVELOPMENT 15 OCT '10	
☐ 90% COORDINATION DMS 18 APRIL '11	
☐ 100% DSA SUBMITTAL 08 JUNE '11	
☐ DSA BRIDGECK SUBMITTAL 15 DEC '11	
☒ DSA BRIDGECK SUBMITTAL 10 JAN '12	

PLUMBING WATER & GAS

P2.3

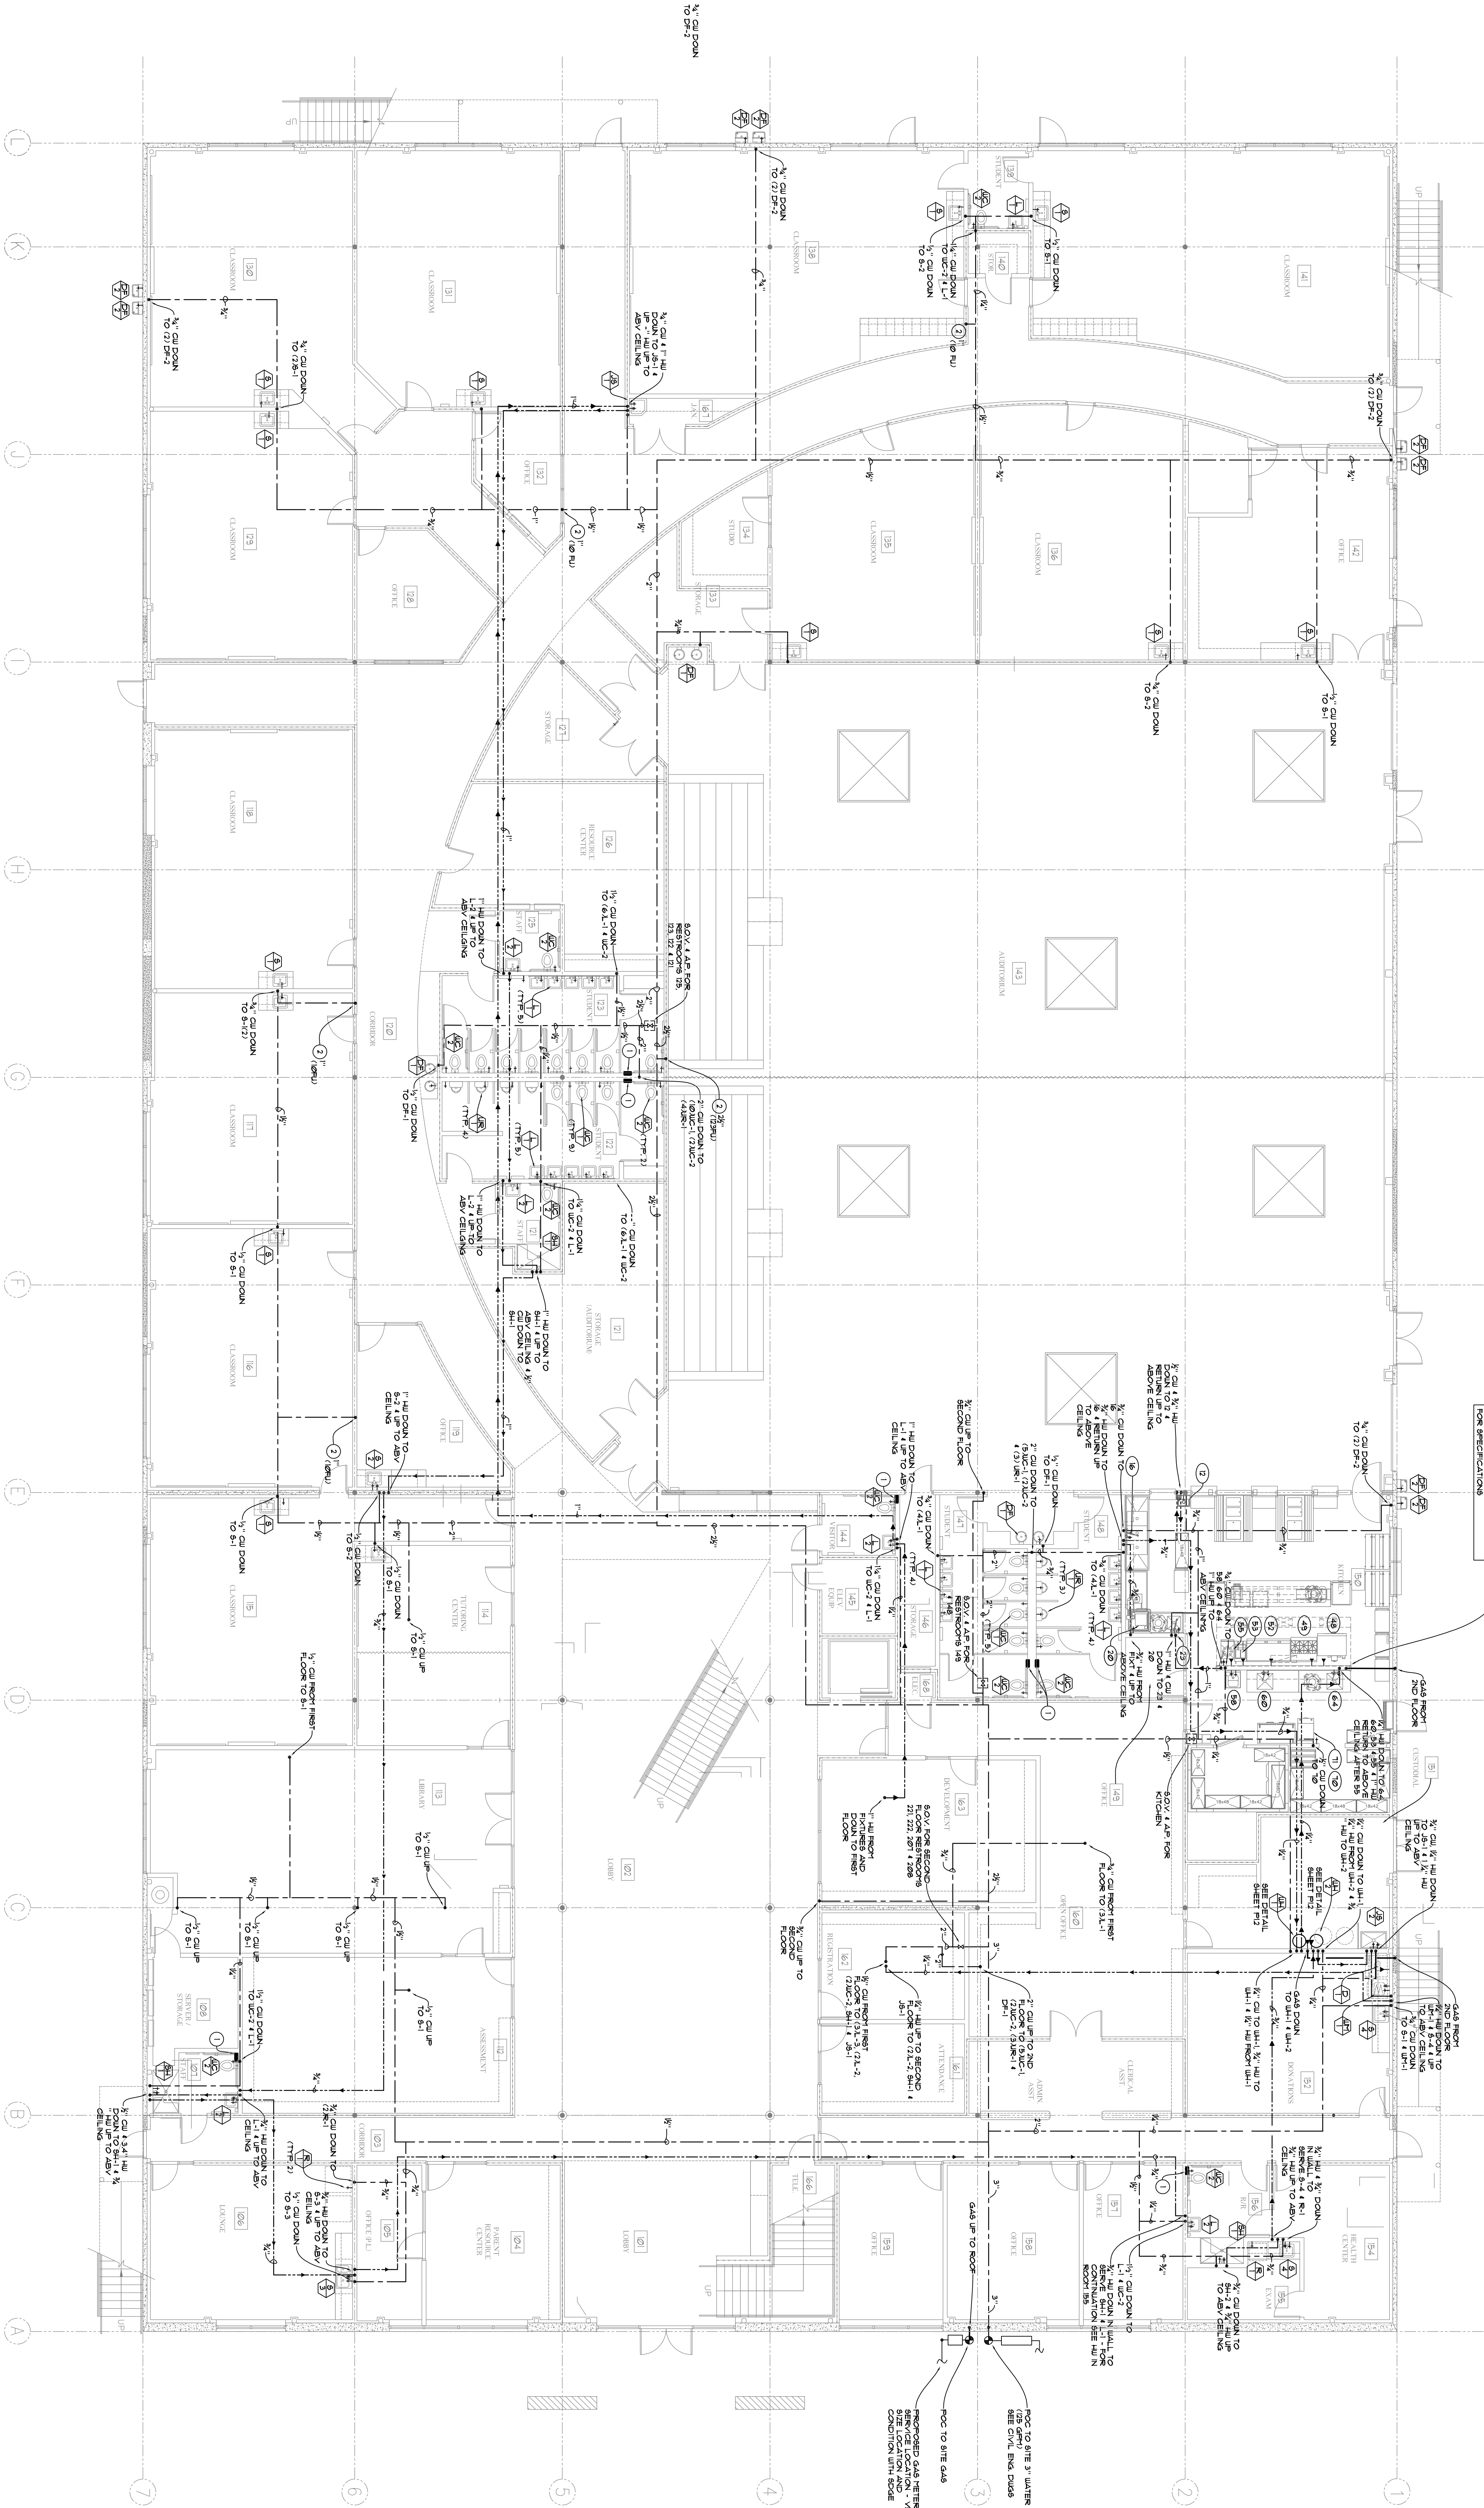

KEY NOTES


1. WATER AND GAS PIPING IS ABOVE THE CEILING UNLESS NOTED OTHERWISE
2. SEE DRAWING P2.1 FOR GAS PIPING IDENTIFICATIONS
3. SEE DRAWING P2.3 FOR GAS PIPING DETAILS
4. DIFFERENCE LOCATIONS SHOWN SHALL BE ON THE LANDSCAPE SYSTEM UNLESS NOTED

FIRST FLOOR PLAN - WATER & GAS



SCALE: 1/8" = 1'-0"


GRAPHIC SCALE

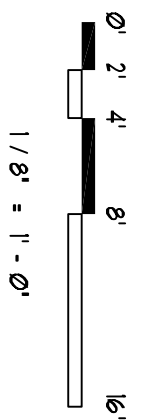

PROJECT NORTH



PLAN NORTH

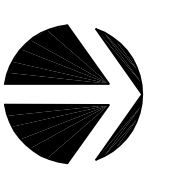

HMD
HARTINGTON MECHANICAL DESIGN, INC.
HVA/C DESIGN • PLUMBING DESIGN
27475 WENZ RD. #246
TERRACAL, CA 92591
TEL (658) 435-4803
FAX (658) 435-4843